


ELECTRICAL LEGEND:-


	5/15A POWER POINT
	16A POWER POINT
	TELEPHONE POINT
	DATA POINT
	WIFI POINT
	AC POWER POINT
	COMPUTER POINT (3NOS, 5A UPS PP, 1NO. DATA POINT, 1NO. 5/15A ROW PP)
	DISTRIBUTION BOARD
	TV POINT

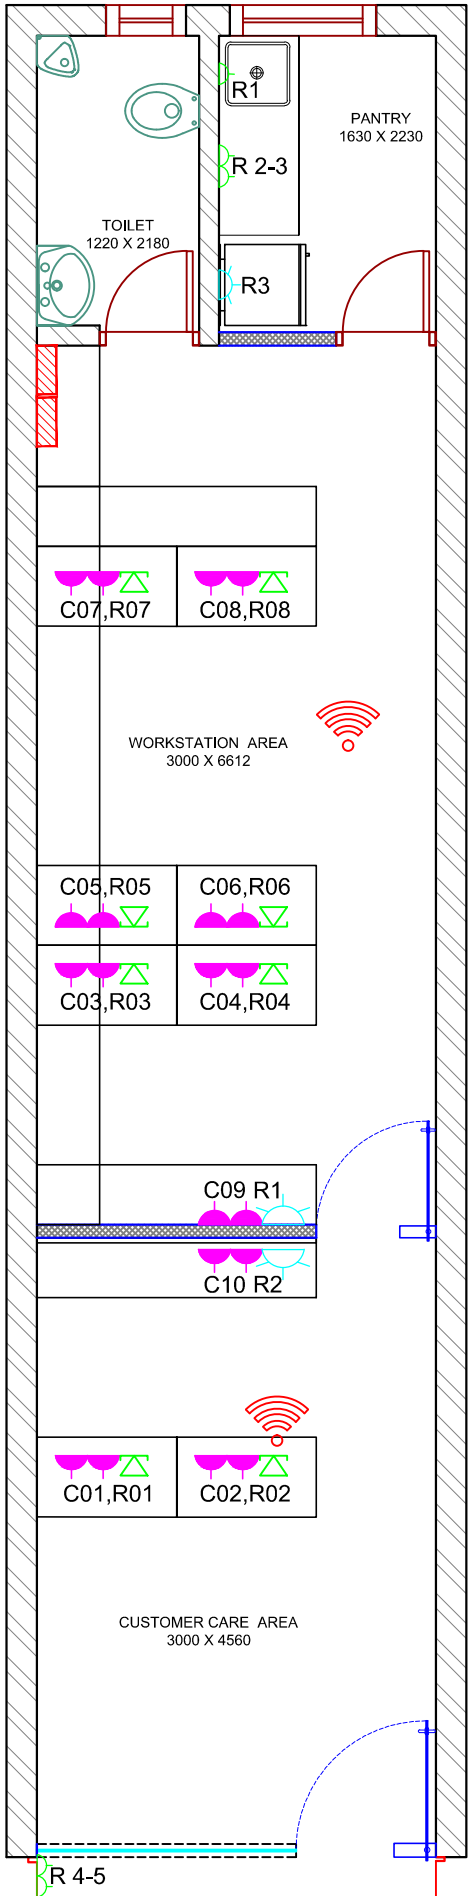

POWER LAYOUT
FIRST FLOOR

LEGEND

	BELOW CEILING IONIZATION SMOKE DETECTOR
	ABOVE CEILING IONIZATION SMOKE DETECTOR
	FIXED HEAT DETECTOR
	RESPONSE INDICATION
	SPEAKER
	DOME CAMERA
	BULLET CAMERA
	12w LED DOWN LIGHT
	HANGING PROFILE LIGHT FITTING
	600 X 600 LED LIGHT FITTING
	18w LED DOWN LIGHT
	SPLIT AC
	CASSETTE AC
	T5 FITTING

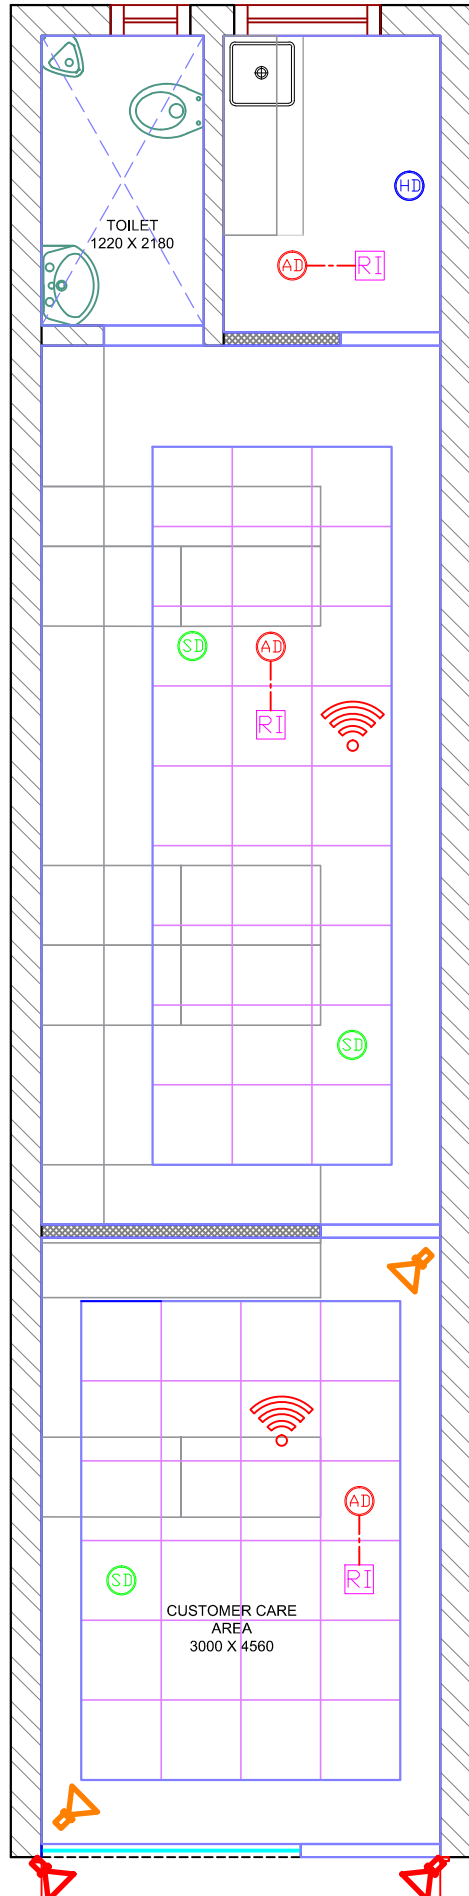

FIRE & CCTV
FIRST FLOOR

GENERAL NOTES :

- All dimensions are in MM.
- Written dimensions are to be followed. The drawing is not to be scaled.
- Any discrepancy in the drawing should be brought to the notice of the architects immediately, and prior to commencing any work from this drawing.
- Any addition or alteration to this drawing should not be made without the written consent of the architects.
- All work shall be executed in accordance with the best practices to relevant Indian standard codes of practice.
- Construction from these drawing is subject to all statutory approvals.
- This drawing must be read in conjunction with other architectural, structural, interior, landscape and utility drawings.
- Indicated all levels are finished.
- Contractor & engineer shall check & verify all dimensions & I/V before execution of the work, & bring to the notice of the architect, any discrepancy.



GUJARAT GAS

GUJARAT GAS LTD.
GUJARAT

FIRE
CONSULTANT:

ELECTRICAL
CONSULTANT:

HVAC
CONSULTANT:

CHECKED

APPROVED

APPROVAL-DRAWING

DATE: SIGNATURE

PURPOSE

R.NO DESCRIPTION DATE

PROJECT :
GUJARAT GAS OFFICE
AT .FIRST FLOOR, MUNDRA OFFICE GUJARAT.

TITLE :
POWER & FIRE & CCTV LAYOUT



PID-AHD-41-25/26 DWG INT-7-8 REV:
NO: DRAWN BY: NAVED
SCALE: N.T.S. CHECKED BY: RAKESH
DATE: 22-12-2025

R0



Sthapati Architecture & Interiors Pvt Ltd.
AHMEDABAD • MUMBAI • DELHI
[www.sthapatigroup.com]
302, Silver Radiance, Nr. Palivan Cross Road, Sindhuvihar Road, Bodakdev,
Ahmedabad-380059. Phone: +91 79 26871665.

Contractors, vendors & consultants must verify all dimension on site and notify this Company any discrepancies prior to carry out works. Written dimensions take precedence over scaled dimensions.
Sthapati Architecture & Interiors Pvt Ltd retains copyright on this drawing.